



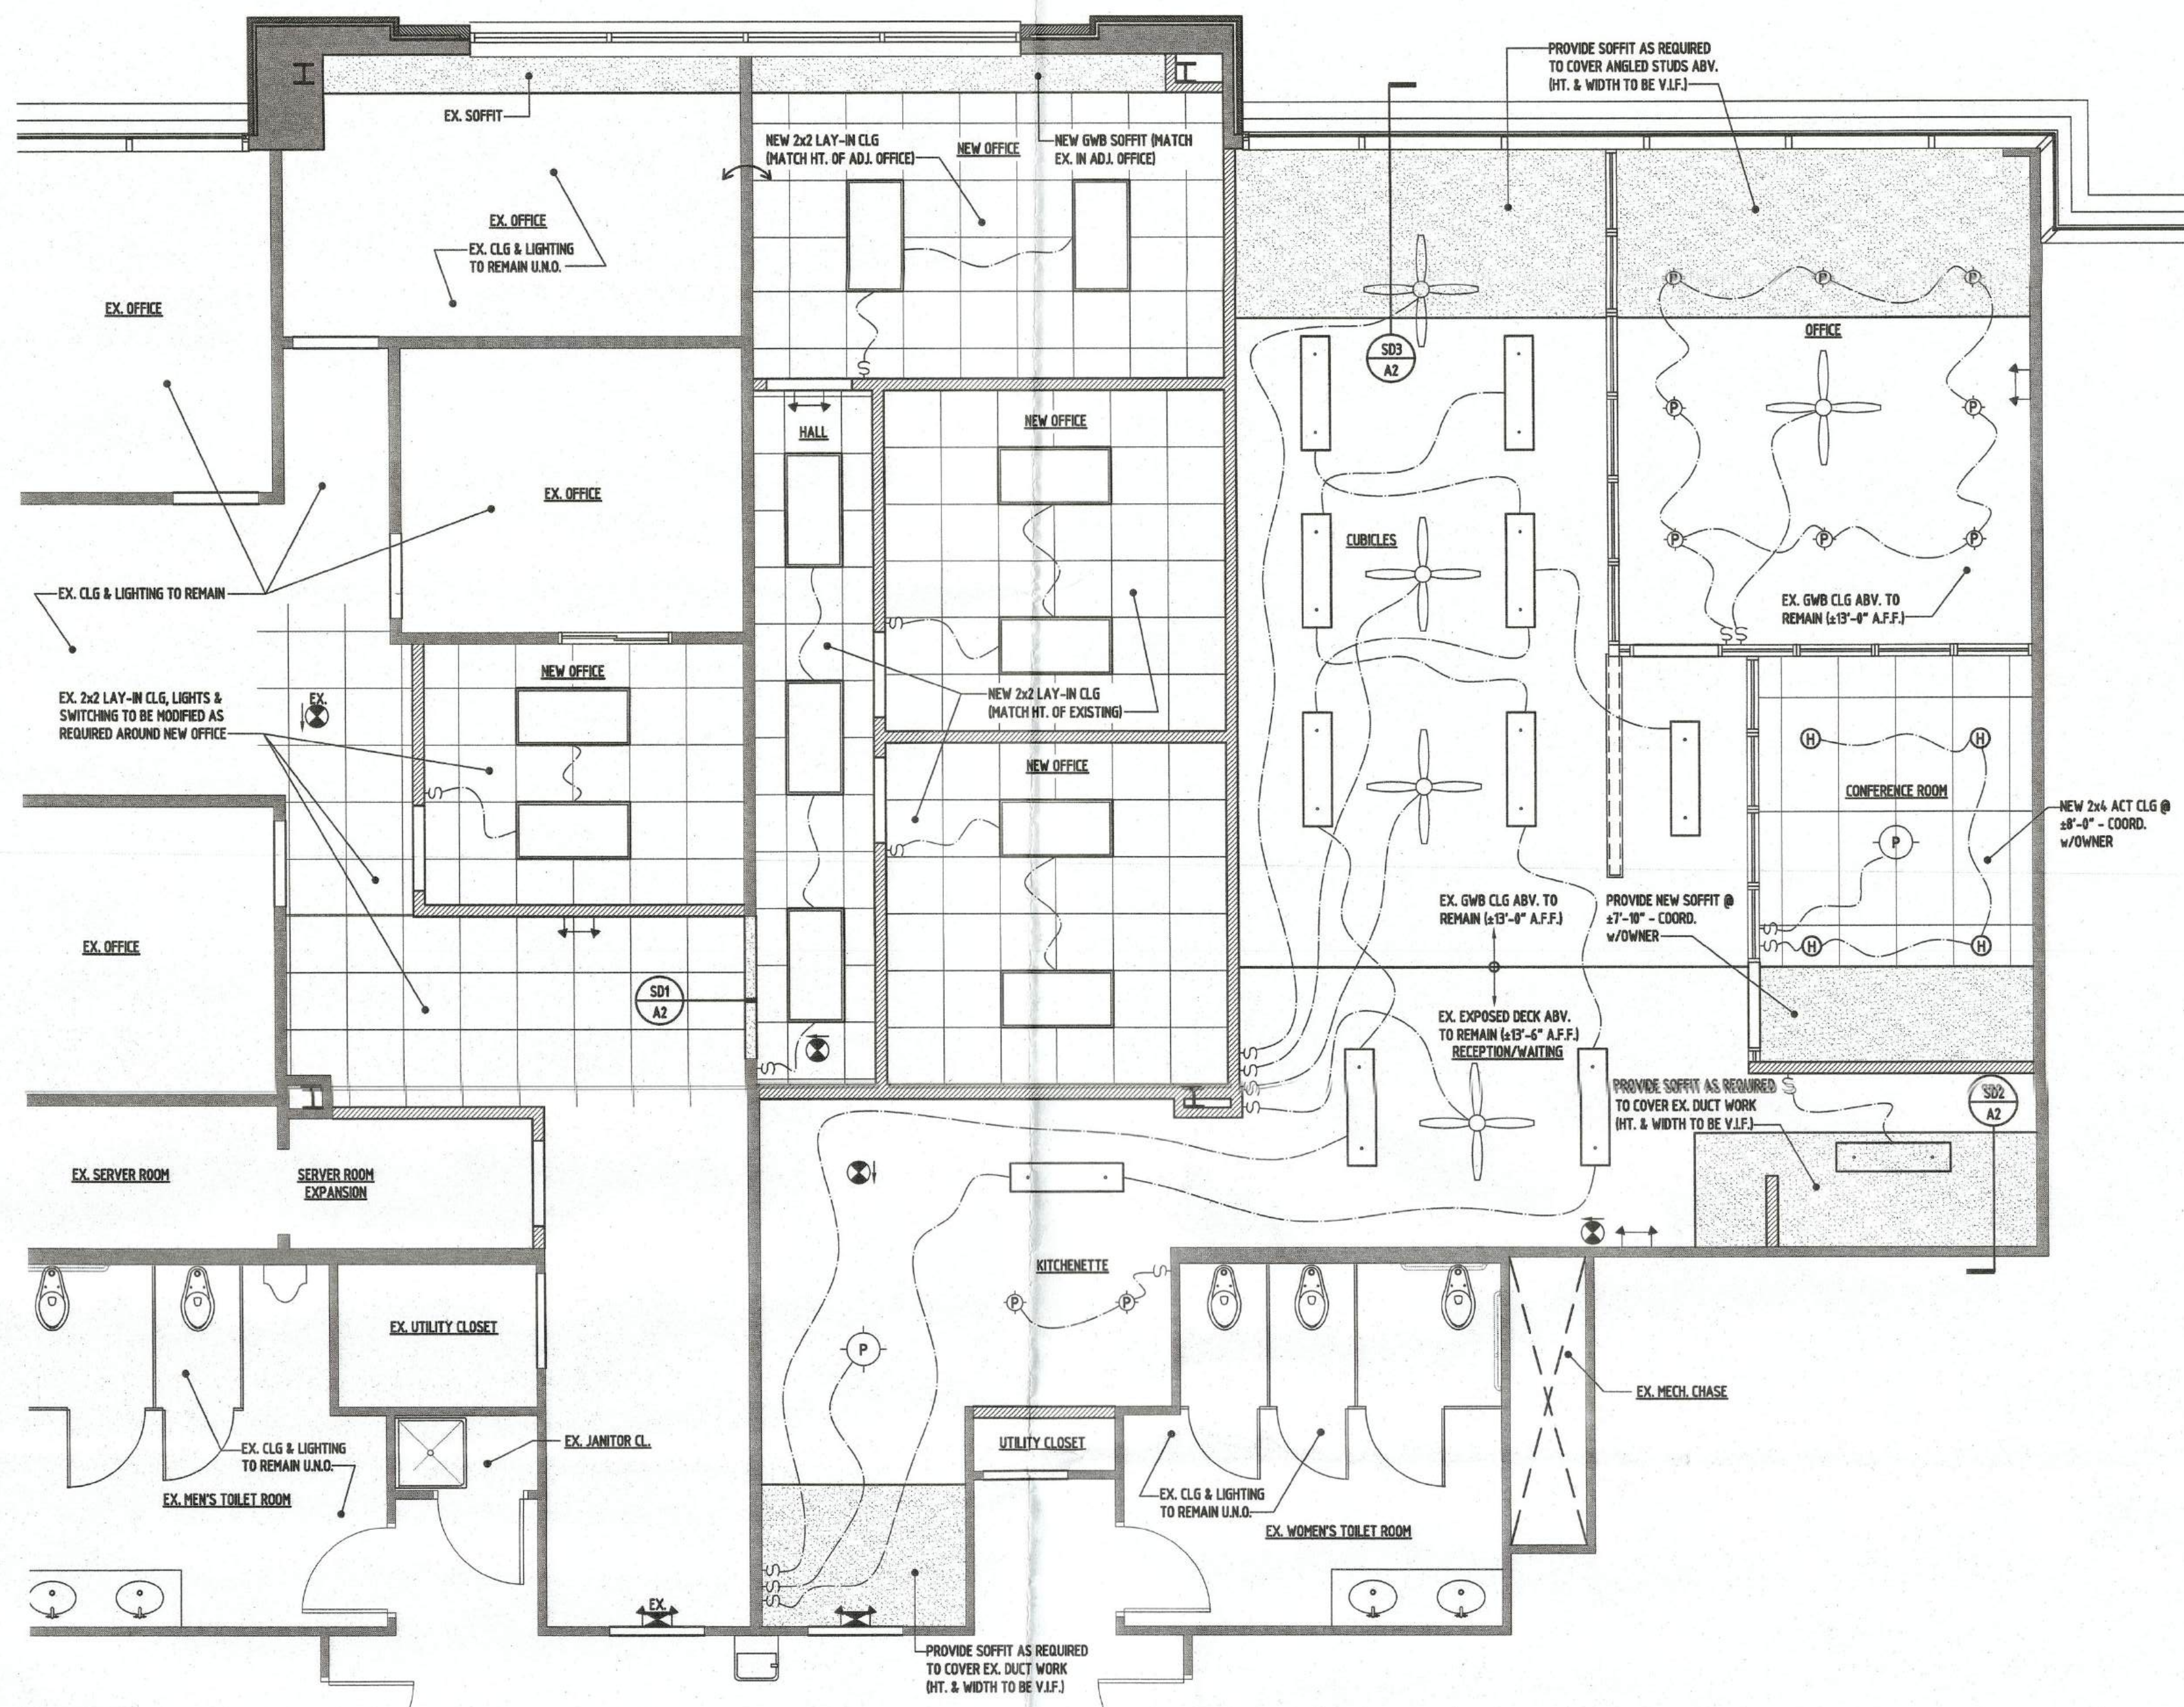

PARTIAL SECOND FLOOR REFLECTED CEILING PLAN


1/4"=1'-0"

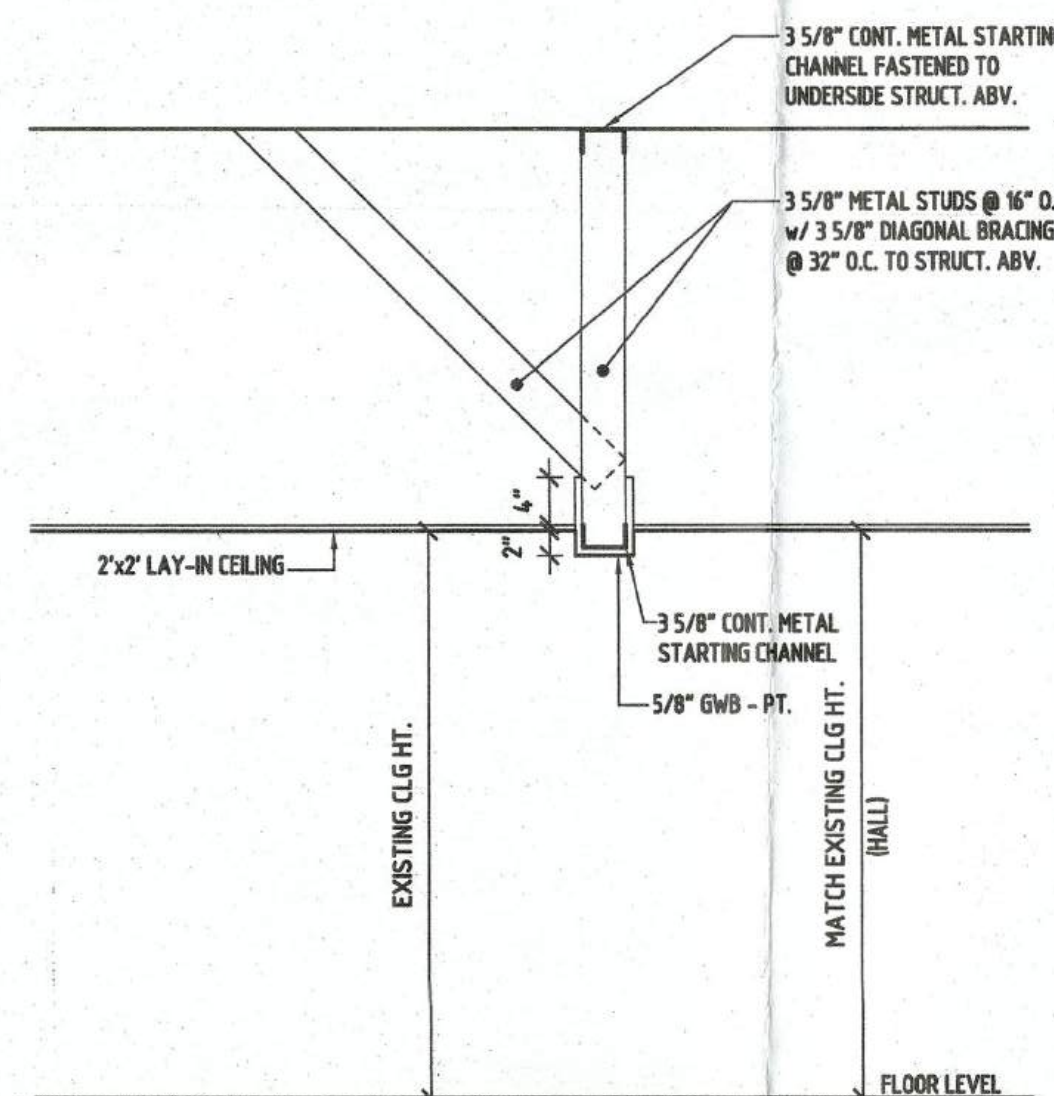

SD1 SOFFIT DETAIL


A2 3/4"=1'-0"

FIXTURE SCHEDULE	
	2'x4' RECESSED LED LIGHT FIXTURE
	7'x4' SUSPENDED LED LIGHT FIXTURE
	PENDANT/CHANDELIER LIGHT FIXTURE
	HIGH HAT LIGHT FIXTURE, RECESSED LIGHTING SHALL MEET ASTM E 283 TYPE IC
	FAN - COORD. w/OWNER
	SINGLE POLE SWITCH
	COMBO INTERNALLY ILLUMINATED EXIT SIGN & DUAL HEAD EMERGENCY LIGHTING FIXTURE w/ BATTERY BACKUP PER CODE
	EMERGENCY LIGHTING FIXTURE w/ BATTERY BACKUP PER CODE
	INTERNALLY ILLUMINATED EXIT SIGN w/ DIRECTIONAL ARROW
NOTE: COORDINATE EXACT FIXTURES, EQUIPMENT, DEVICES, ETC. w/ ELECTRICAL CONTRACTOR & OWNER	

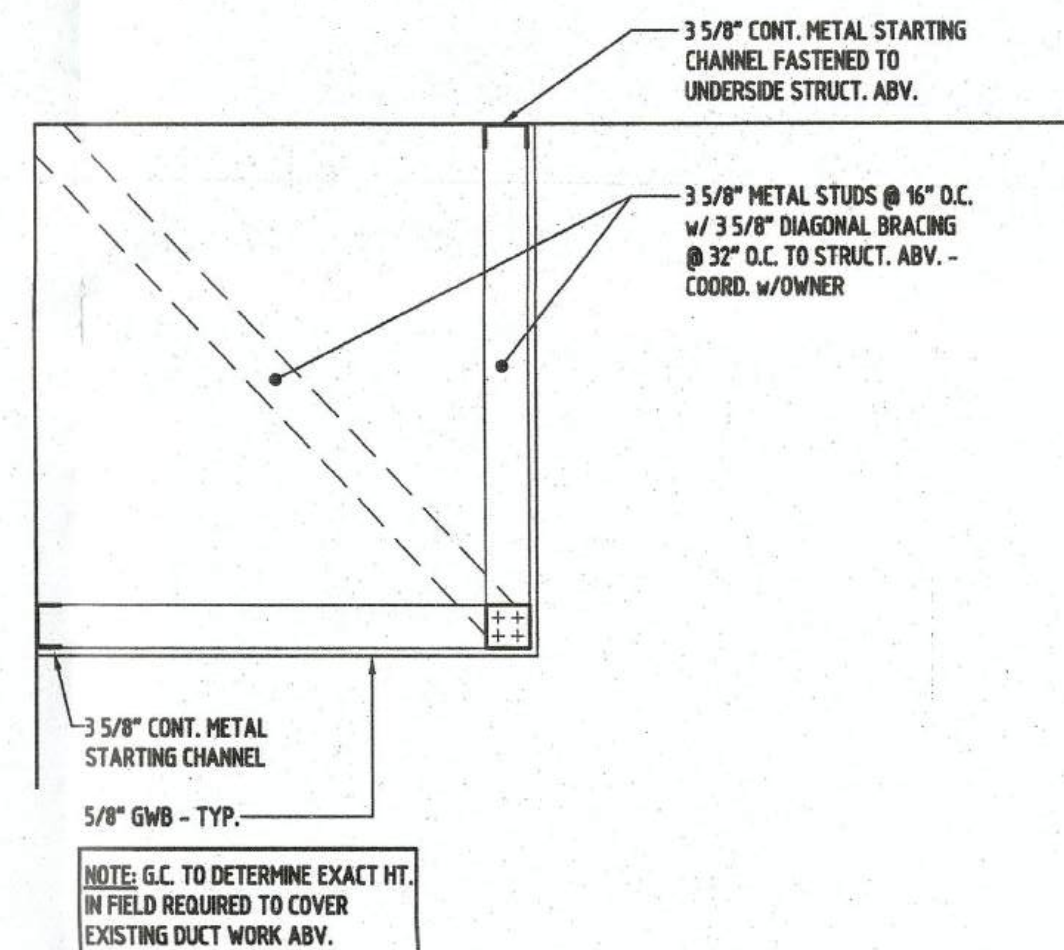


SD2 SOFFIT DETAIL

A2 3/4"=1'-0"

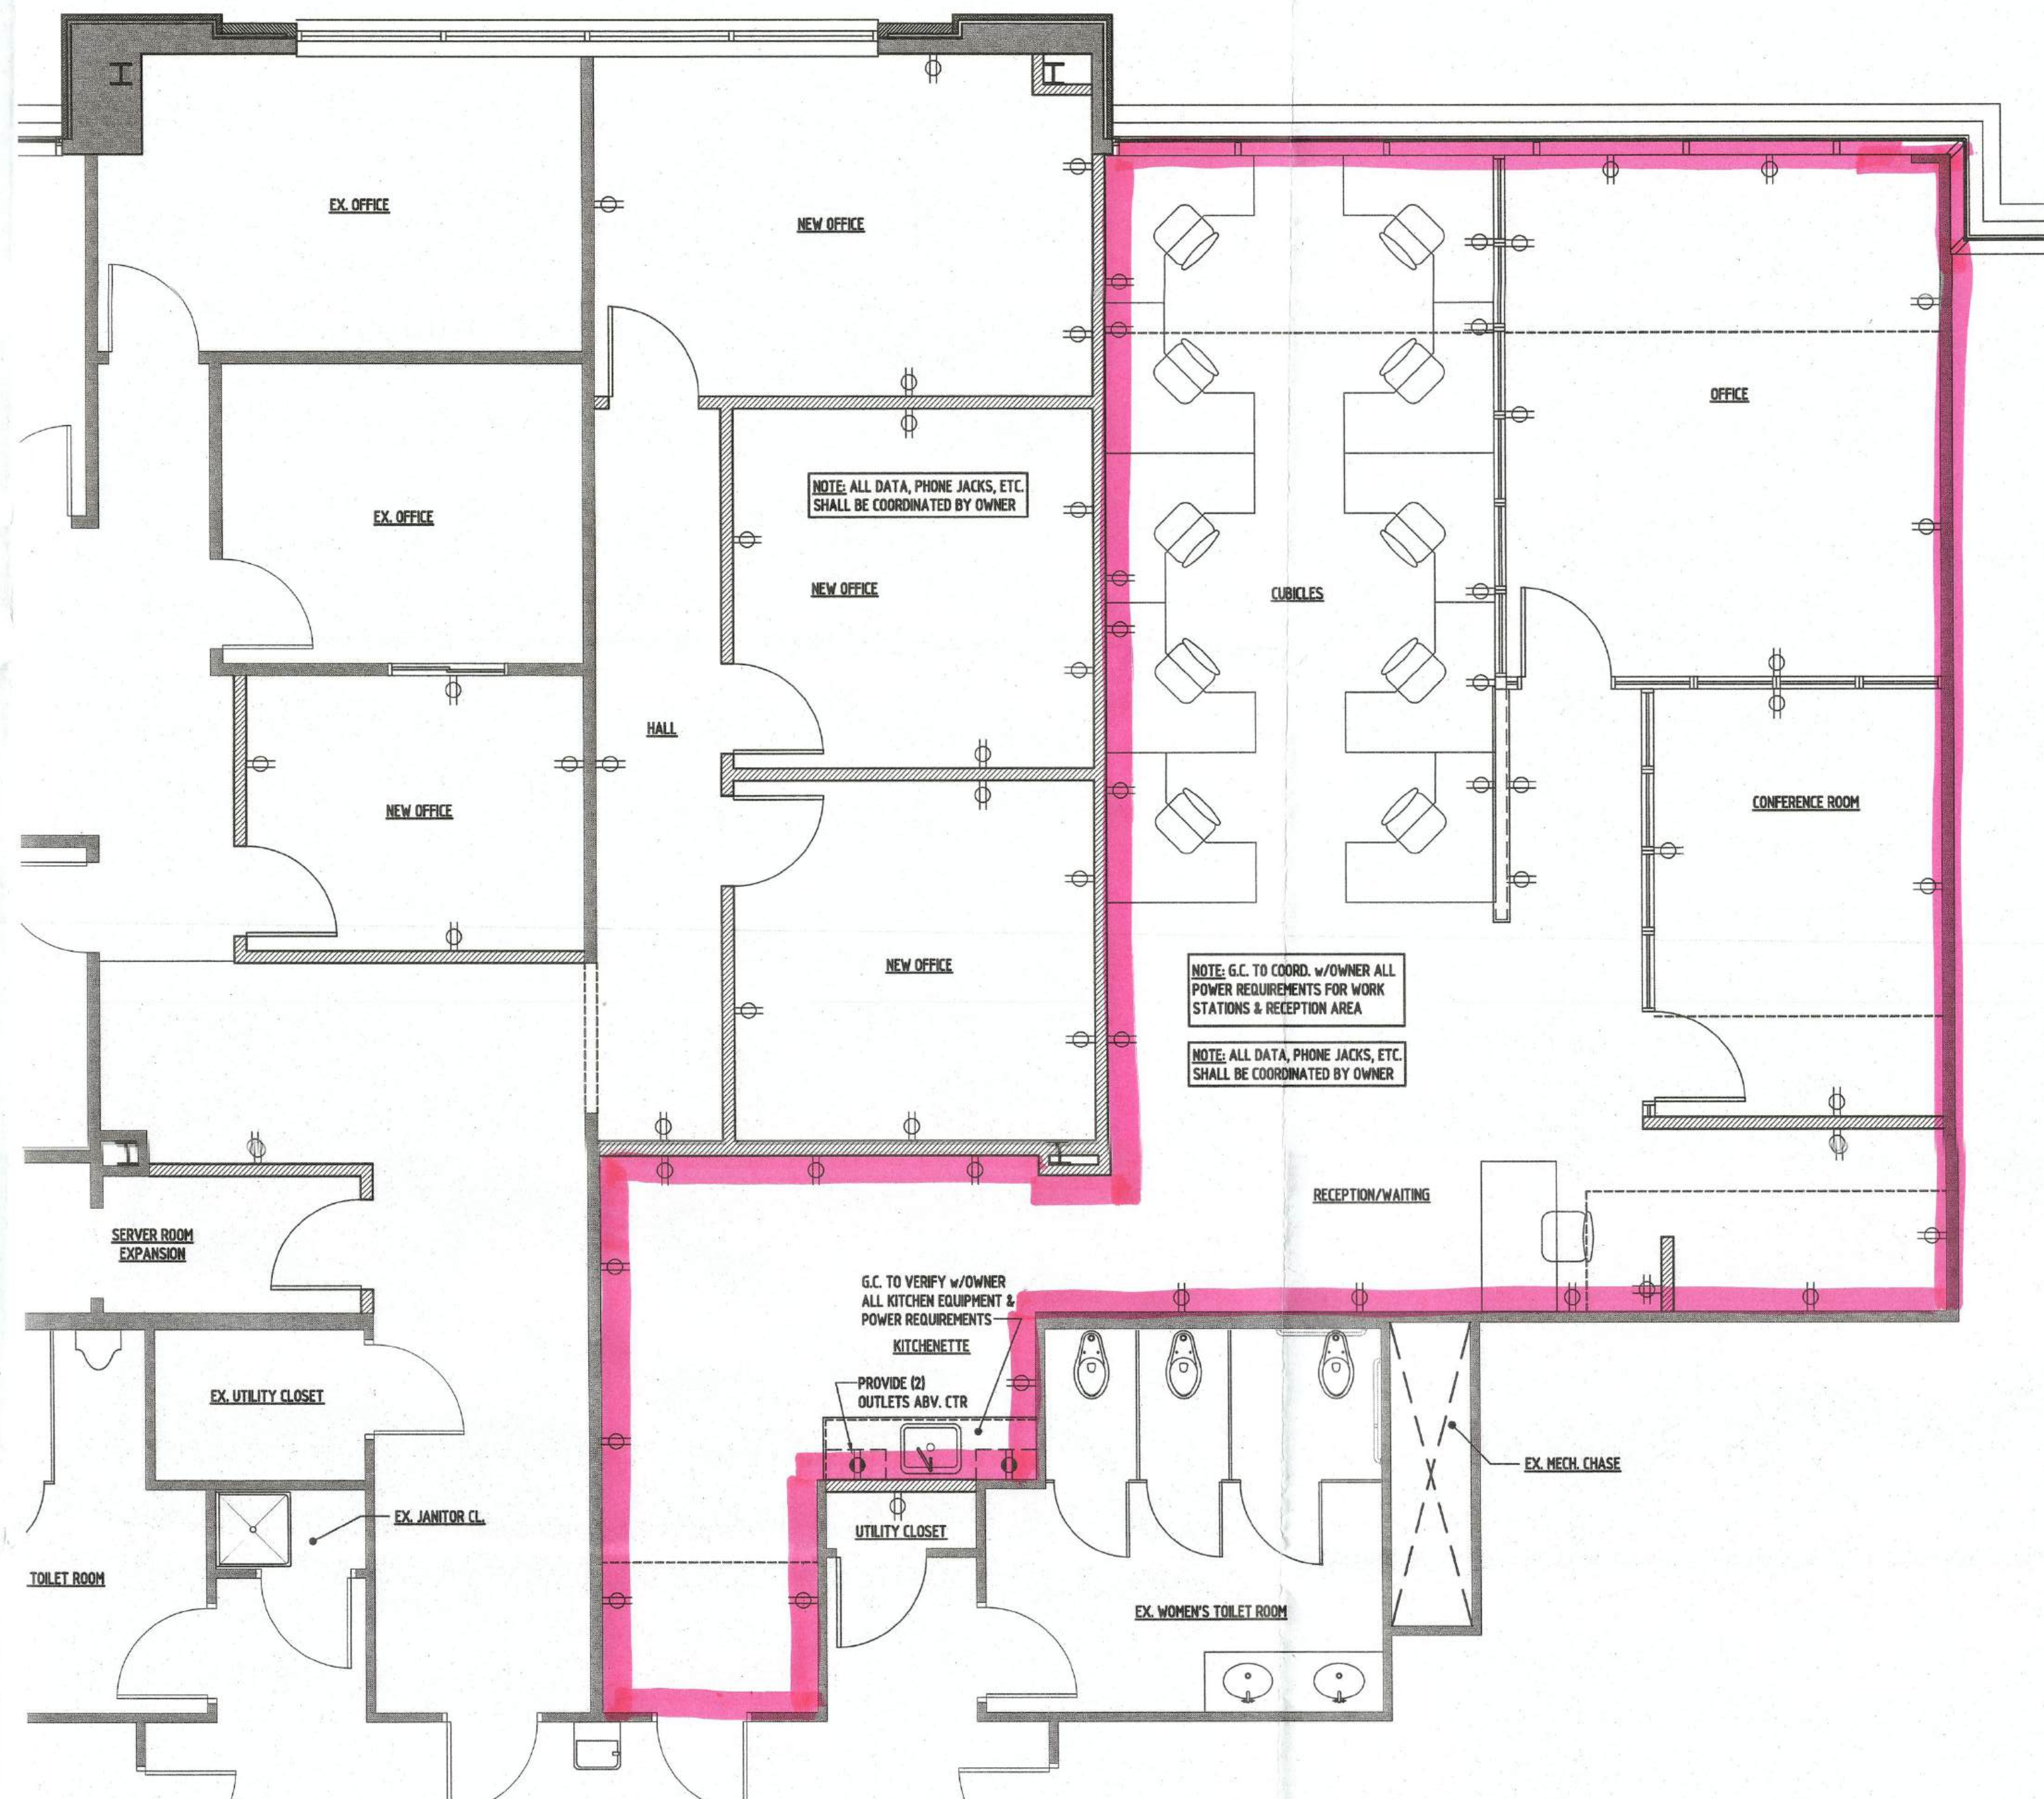

PARTIAL SECOND FLOOR ELECTRICAL PLAN

1/4"=1'-0"

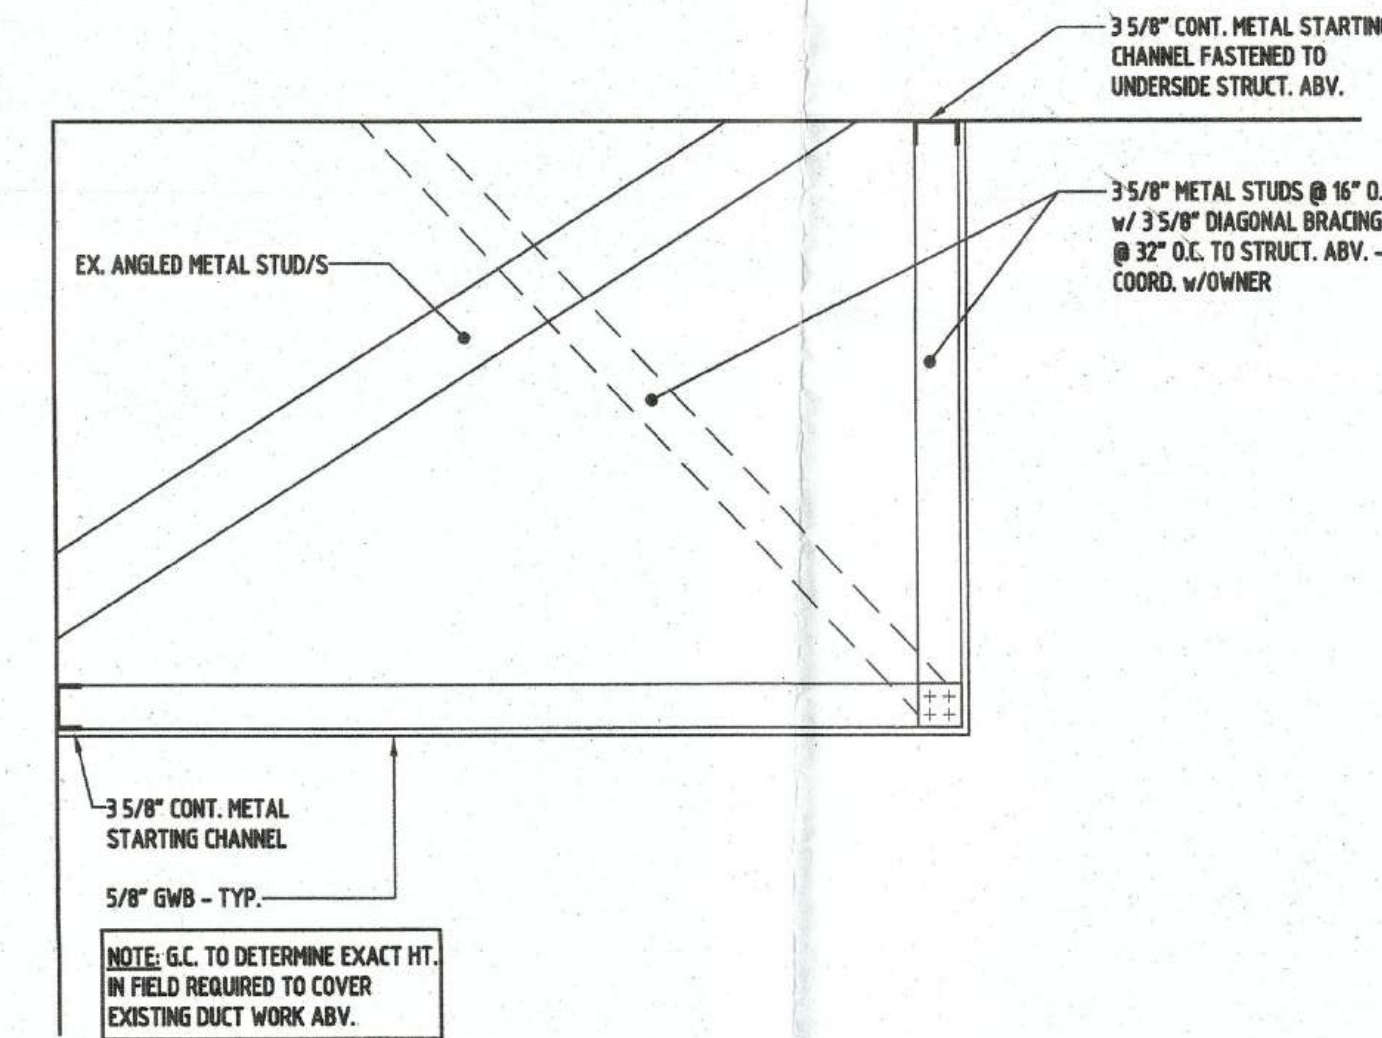


SD3 SOFFIT DETAIL

A2 3/4"=1'-0"

GENERAL NOTE:
DESIGNER'S RESPONSIBILITY FOR GRAPHIC PURPOSES ONLY. CONSULTANT, DESIGNERS, CONTRACTORS AND OTHERS SHALL BE RESPONSIBLE FOR VERIFYING ALL PRESENT AND EXISTING CONDITIONS, DIMENSIONS, ETC. BEFORE PROCEEDING WITH WORK.

Matthew V. Piotrowski
Architect, LLC
330 Evergreen Ave
Warminster, PA 18974
215.675.2099

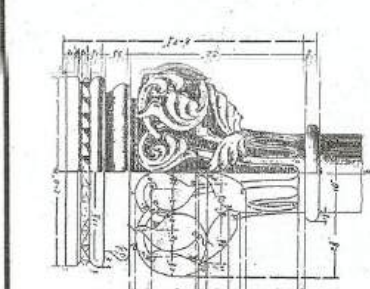

OFFICE BUILDING
M&Q & KELLER WILLIAMS INTERIOR RENO
542 N. LEWIS RD.
ROYERSFORD, PA 19468

Drawn By: JPL
Checked By: MVP

Date: 10/2/17
Issue: Design Review

10/26/17 For Permit

2017187

DO NOT SCALE DRAWINGS

A2
2nd FLR RCP & ELECTRICAL
PLAN & DETAILS