


GREEN DESIGN • CHURCHES  
 COMMERCIAL • RESIDENTIAL  
 ACCESSIBILITY • MASTER PLANS

T: 215.393.9192  
 F: 215.393.3637  
 C: 267.664.3721  
 E: LEZENBY@AOL.COM

724 DERSTINE AVENUE  
 LANSDALE, PA 19446

www.lezenbyarchitects.com

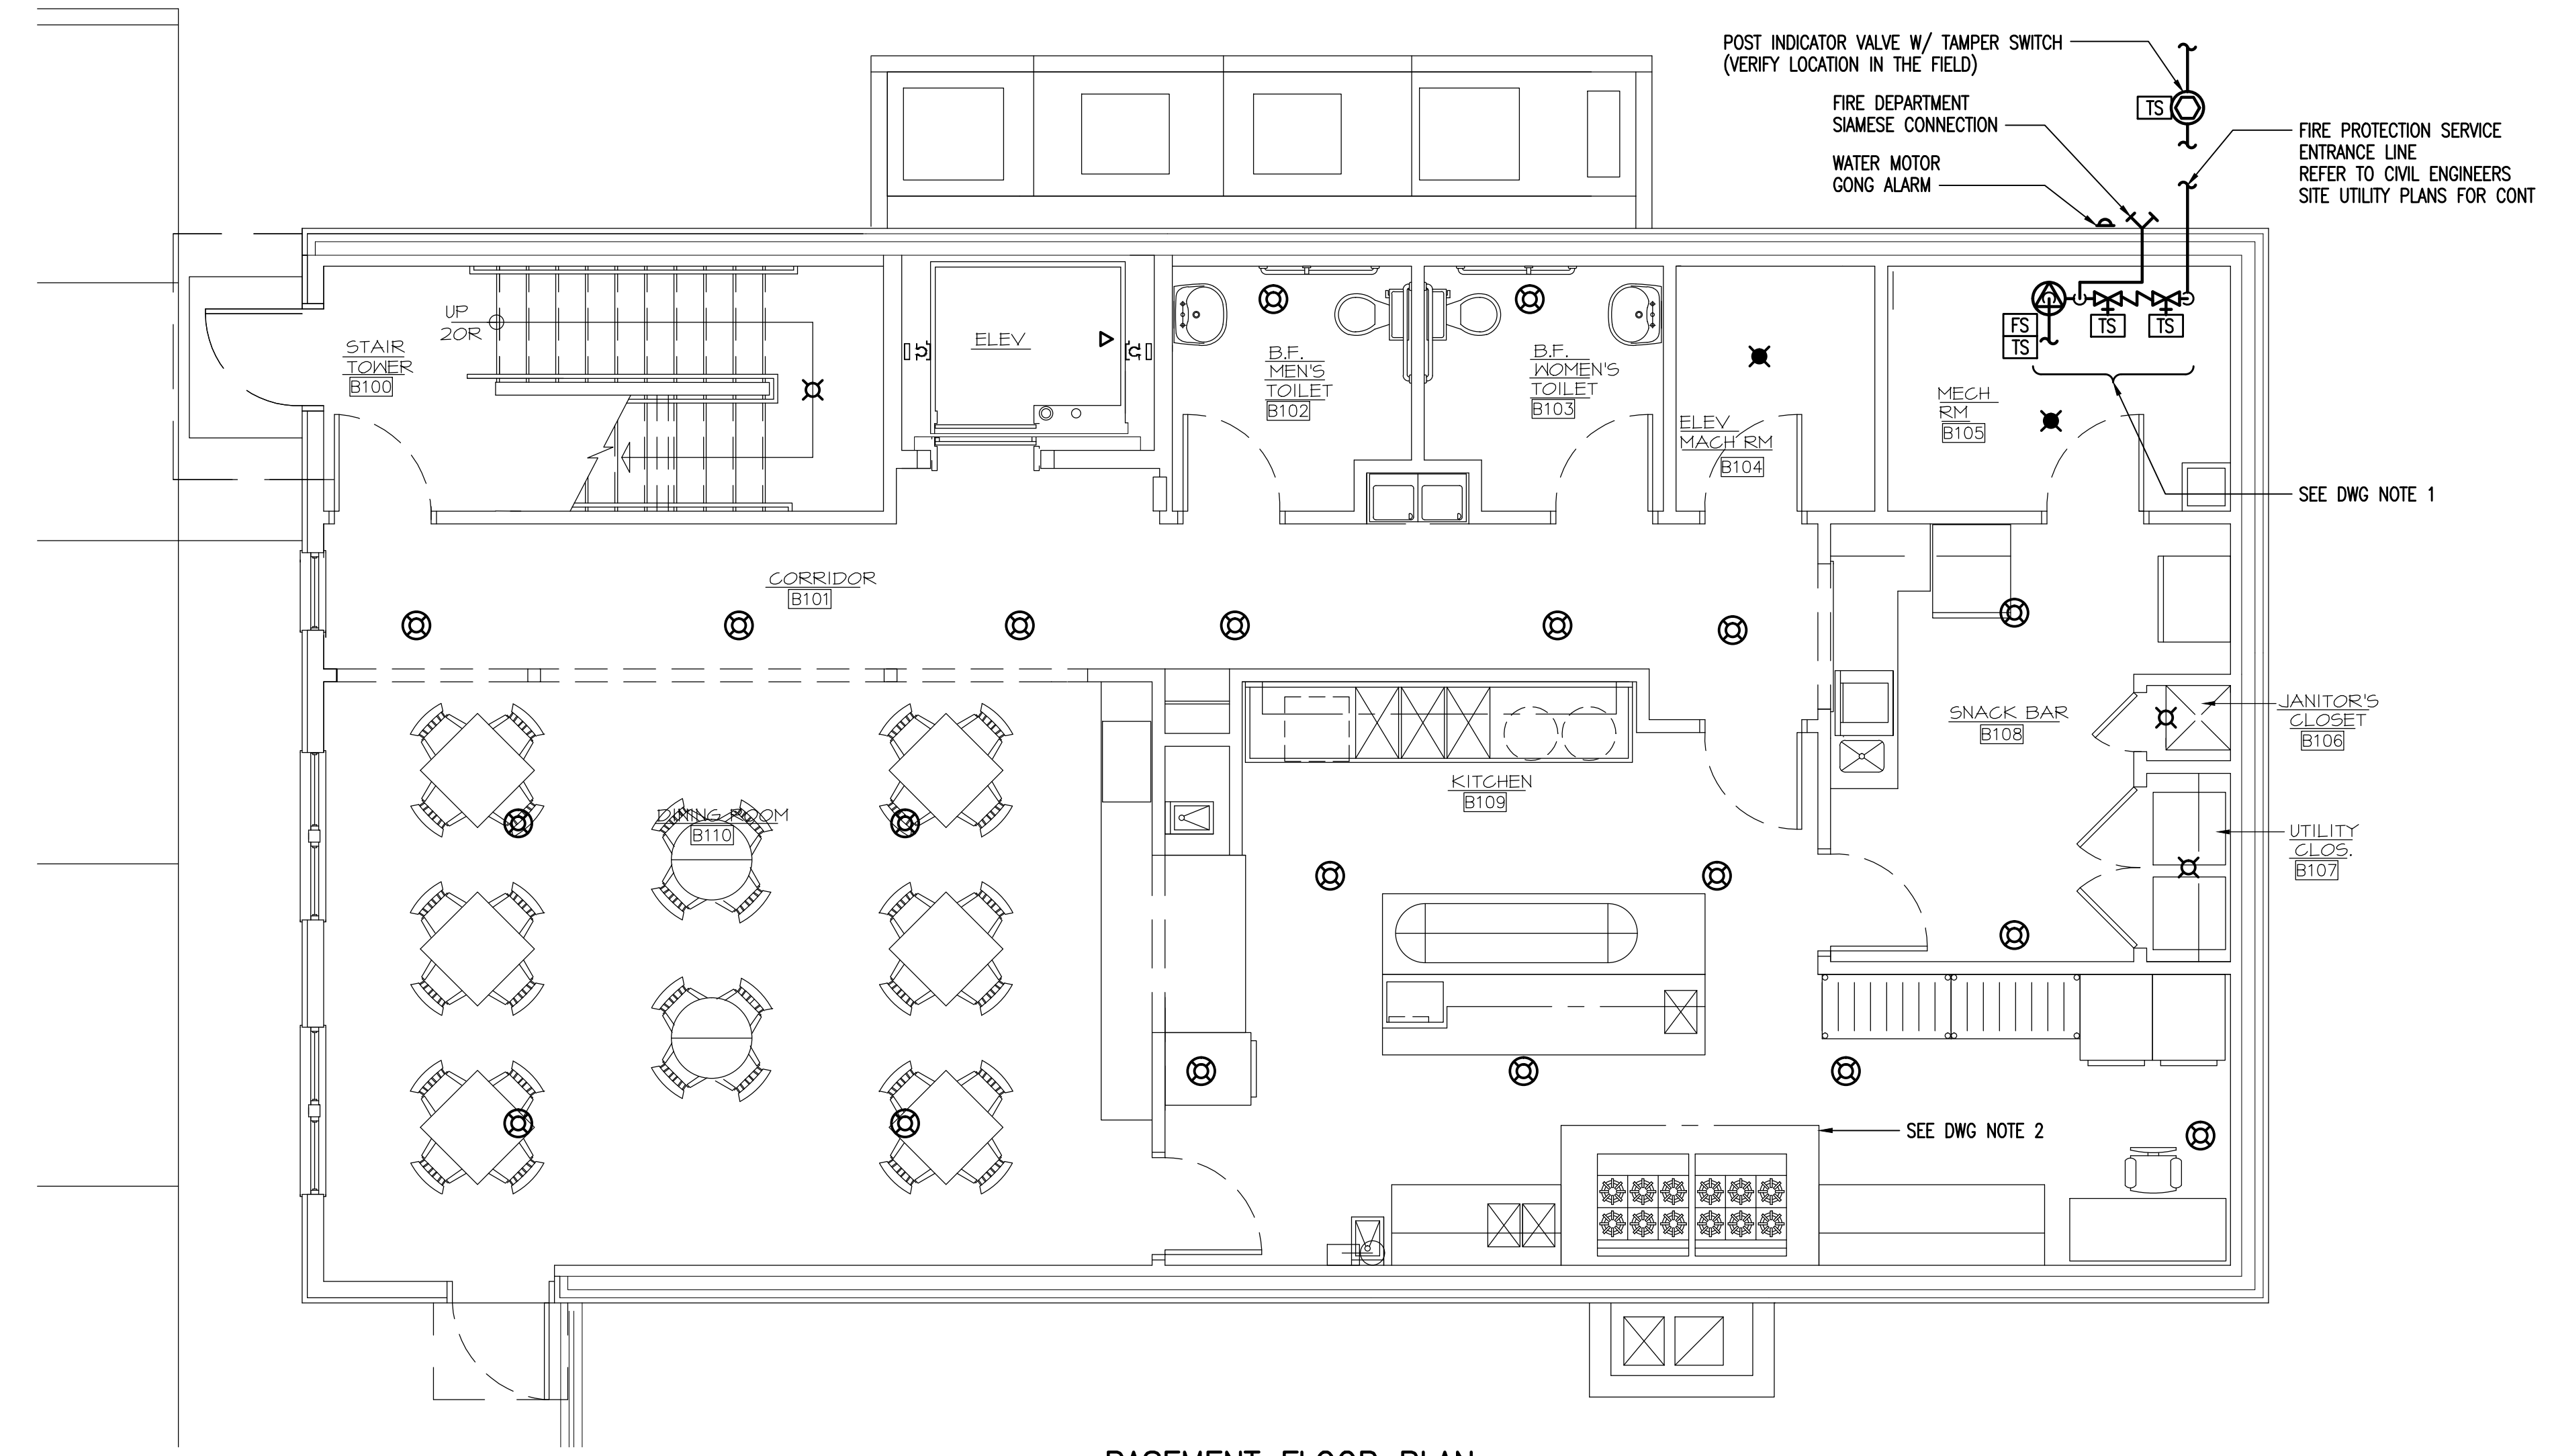

**BASEMENT FLOOR PLAN**  
 SCALE: 1/4" = 1'-0" (FN FLR EL 106.34')

**DRAWING NOTES:**

- SEE "FIRE SERVICE ENTRANCE AND ALARM CHECK RISER VALVE DIAGRAM" ON DRAWING FP1.1 FOR PIPING AND VALVE ARRANGEMENT. COORDINATE LOCATION OF FIRE PROTECTION WATER SERVICE ENTRANCE EQUIPMENT WITH DOMESTIC SERVICE ENTRANCE EQUIPMENT.
- FIRE SUPPRESSION SYSTEM IS INTEGRAL WITH KITCHEN HOOD, KITCHEN HOOD TO BE FURNISHED AND INSTALLED BY FOOD SERVICE SUPPLIER

Proposed New Building for  
**Hedwig House, Inc.**

1920 Old York Road  
 Abington, PA 19001  
 Abington Township, Montgomery County

SHEET TITLE: **Basement Floor Plan**

SCALE: 1/4"=1'-0"

DATE	REVISIONS	DESCRIPTION	DATE	DESIGN
06.16.2010			04.29.2011	Design
07.13.2010	Zemina		11.15.2011	Final Check Set
08.23.2010			11.18.2011	Big Set
09.22.2010				Design
10.21.2010				Design

SHEET NUMBER

**FP2.1**